


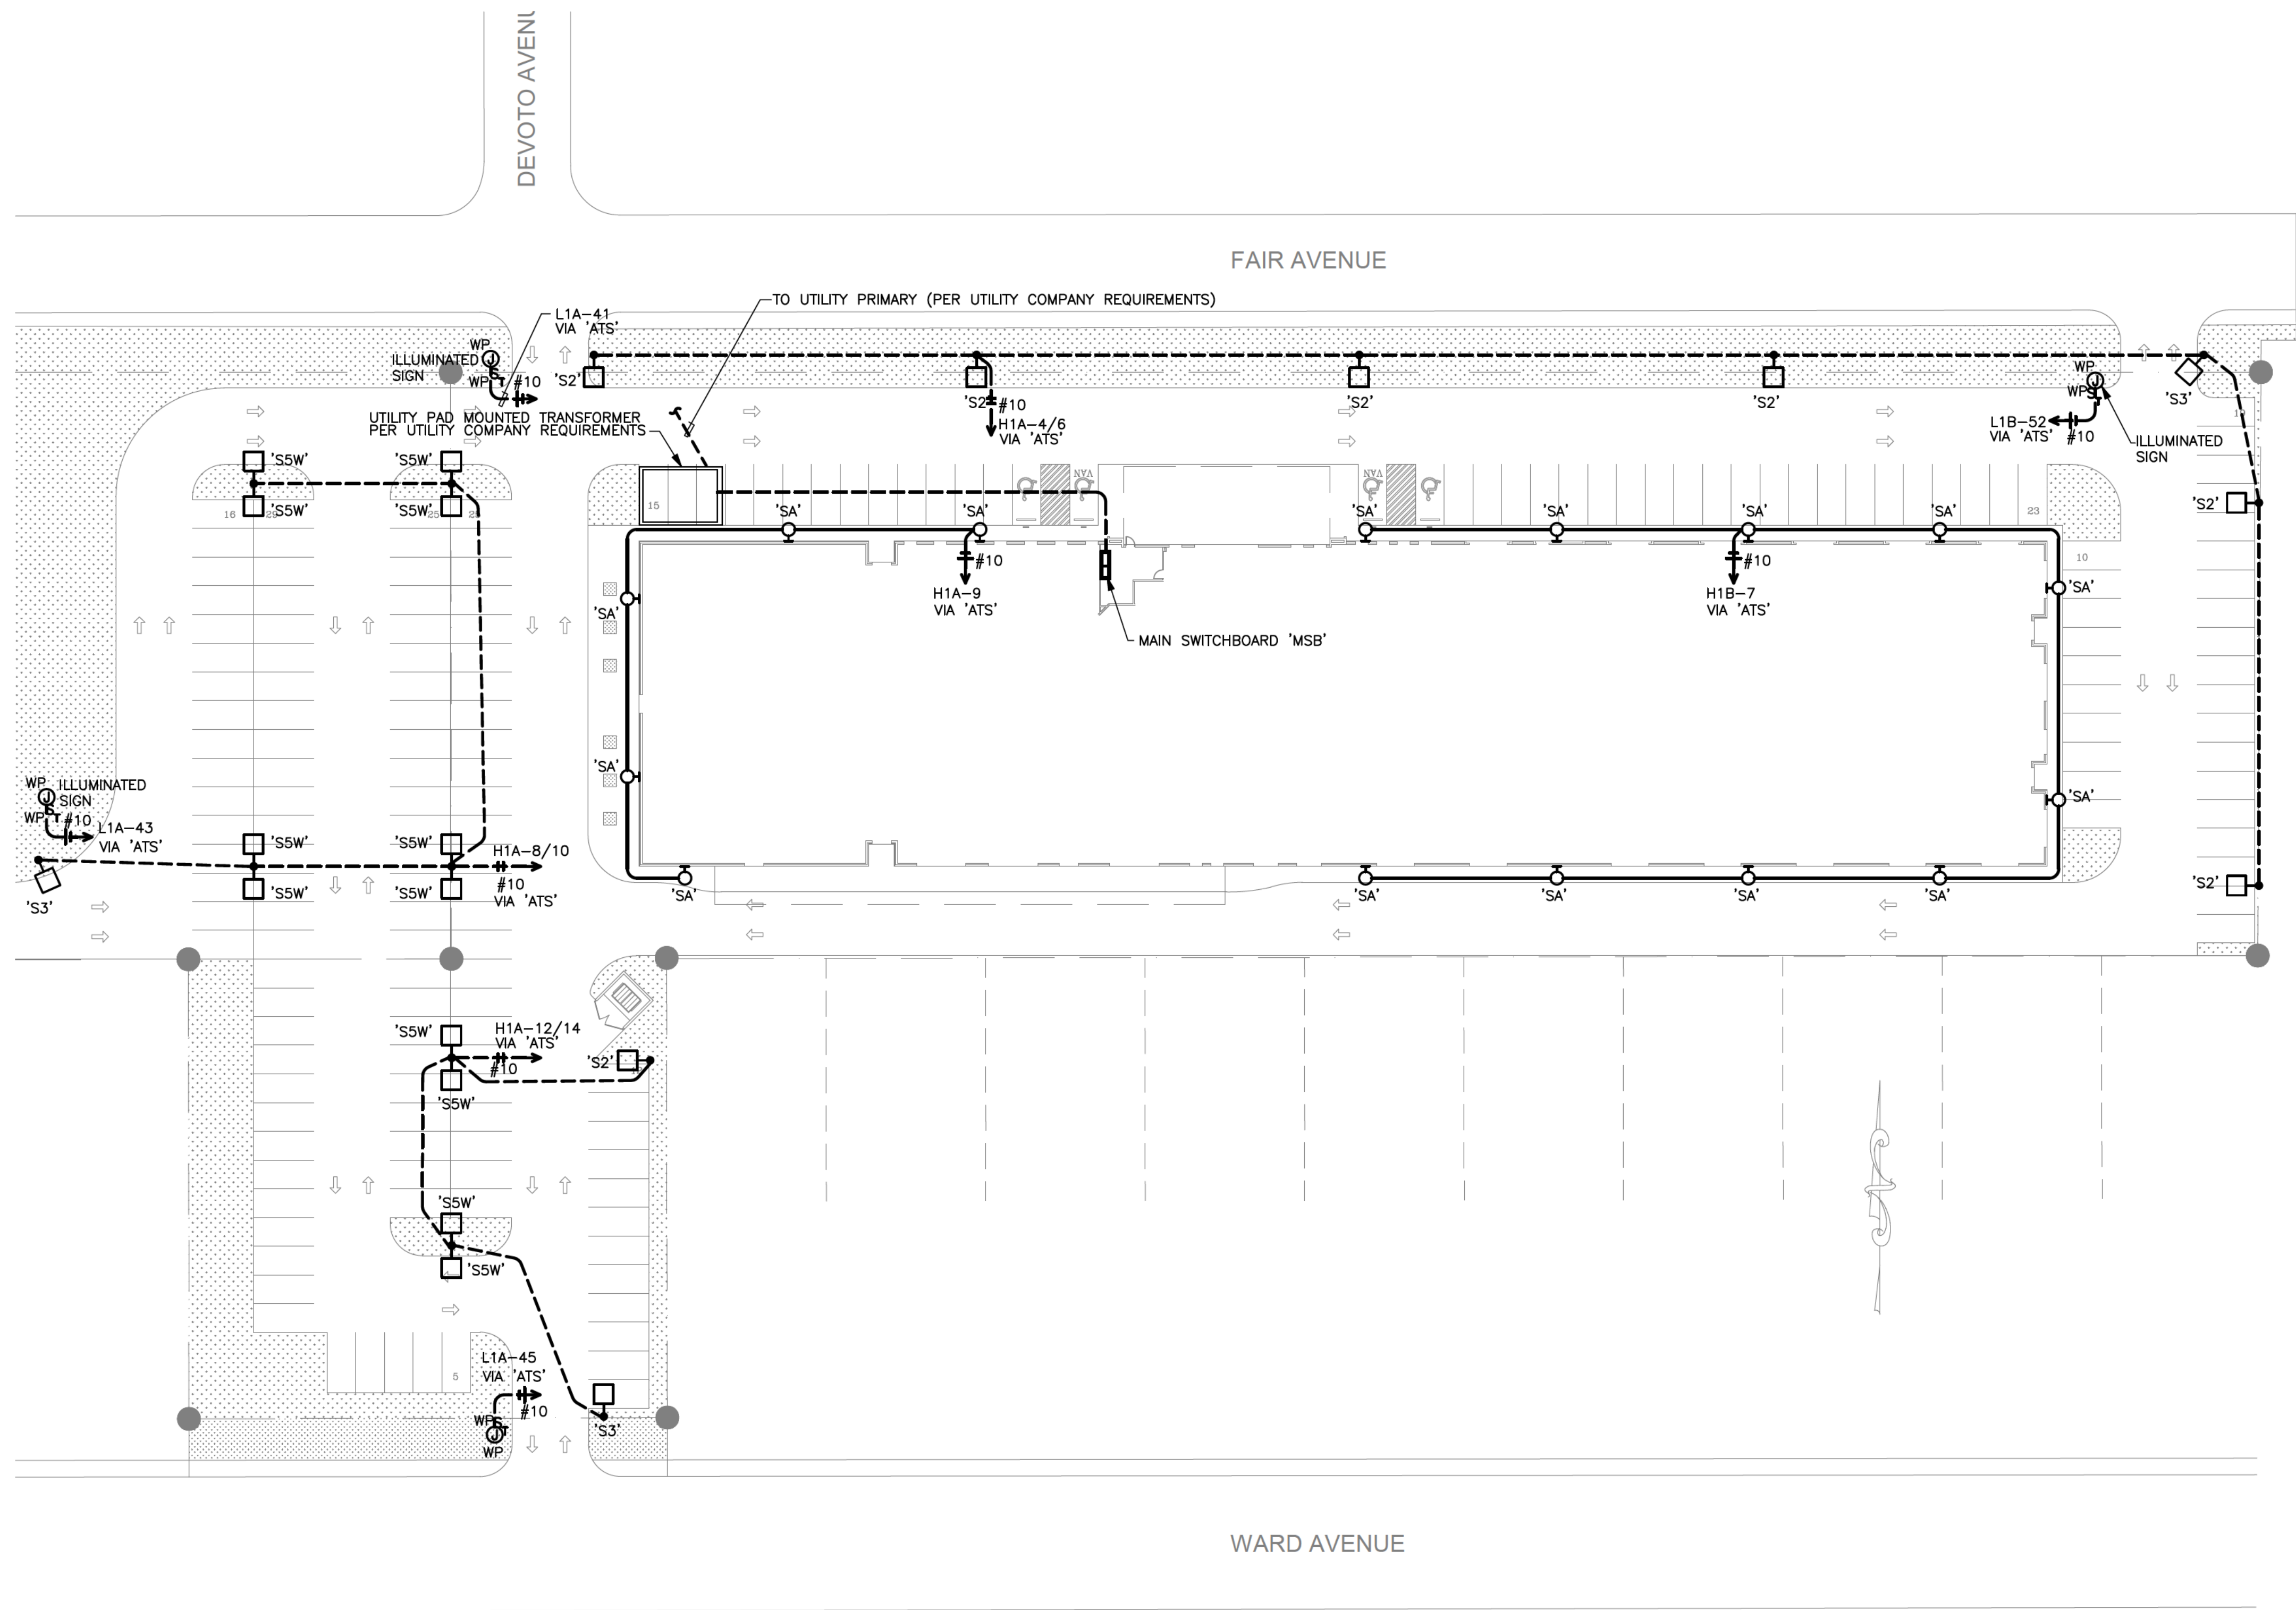

1 ELECTRICAL SITE PLAN
SCALE: 1/32"=1'-0"

PROPRIETARY NOTICE:
Bullseye Engineering Inspection INC.
Reserves all rights to the content
of this document. Any use of the
contents of this documents or
reproduction thereof in any form
shall not be made without prior
written authorization. Acceptance of
this documents shall be
acknowledged agreement of the
Proprietary Notice.

Drawn By: AB
Designed By: HO
Checked By: HO

Bullseye Engineering Inspection, LLC

1601 Industrial Blvd
Suite 3037
Sugar Land, TX 77478

Firm number #: 20186
PHONE: 832-633-0496

\\bullseye\engineering\project\20186\20186.dwg

ELECTRICAL SITE PLAN



REVISIONS

No.	DATE	DESCRIPTION
1	02-05-2024	ISSUE FOR PERMIT
2	REV_DATE	
3	REV_DATE	
4	REV_DATE	
5	REV_DATE	

DATE
02/05/24

SHEET NUMBER
E1.0